




1 COMMUNICATIONS OUTLET WALL INSTALLATION
NTS

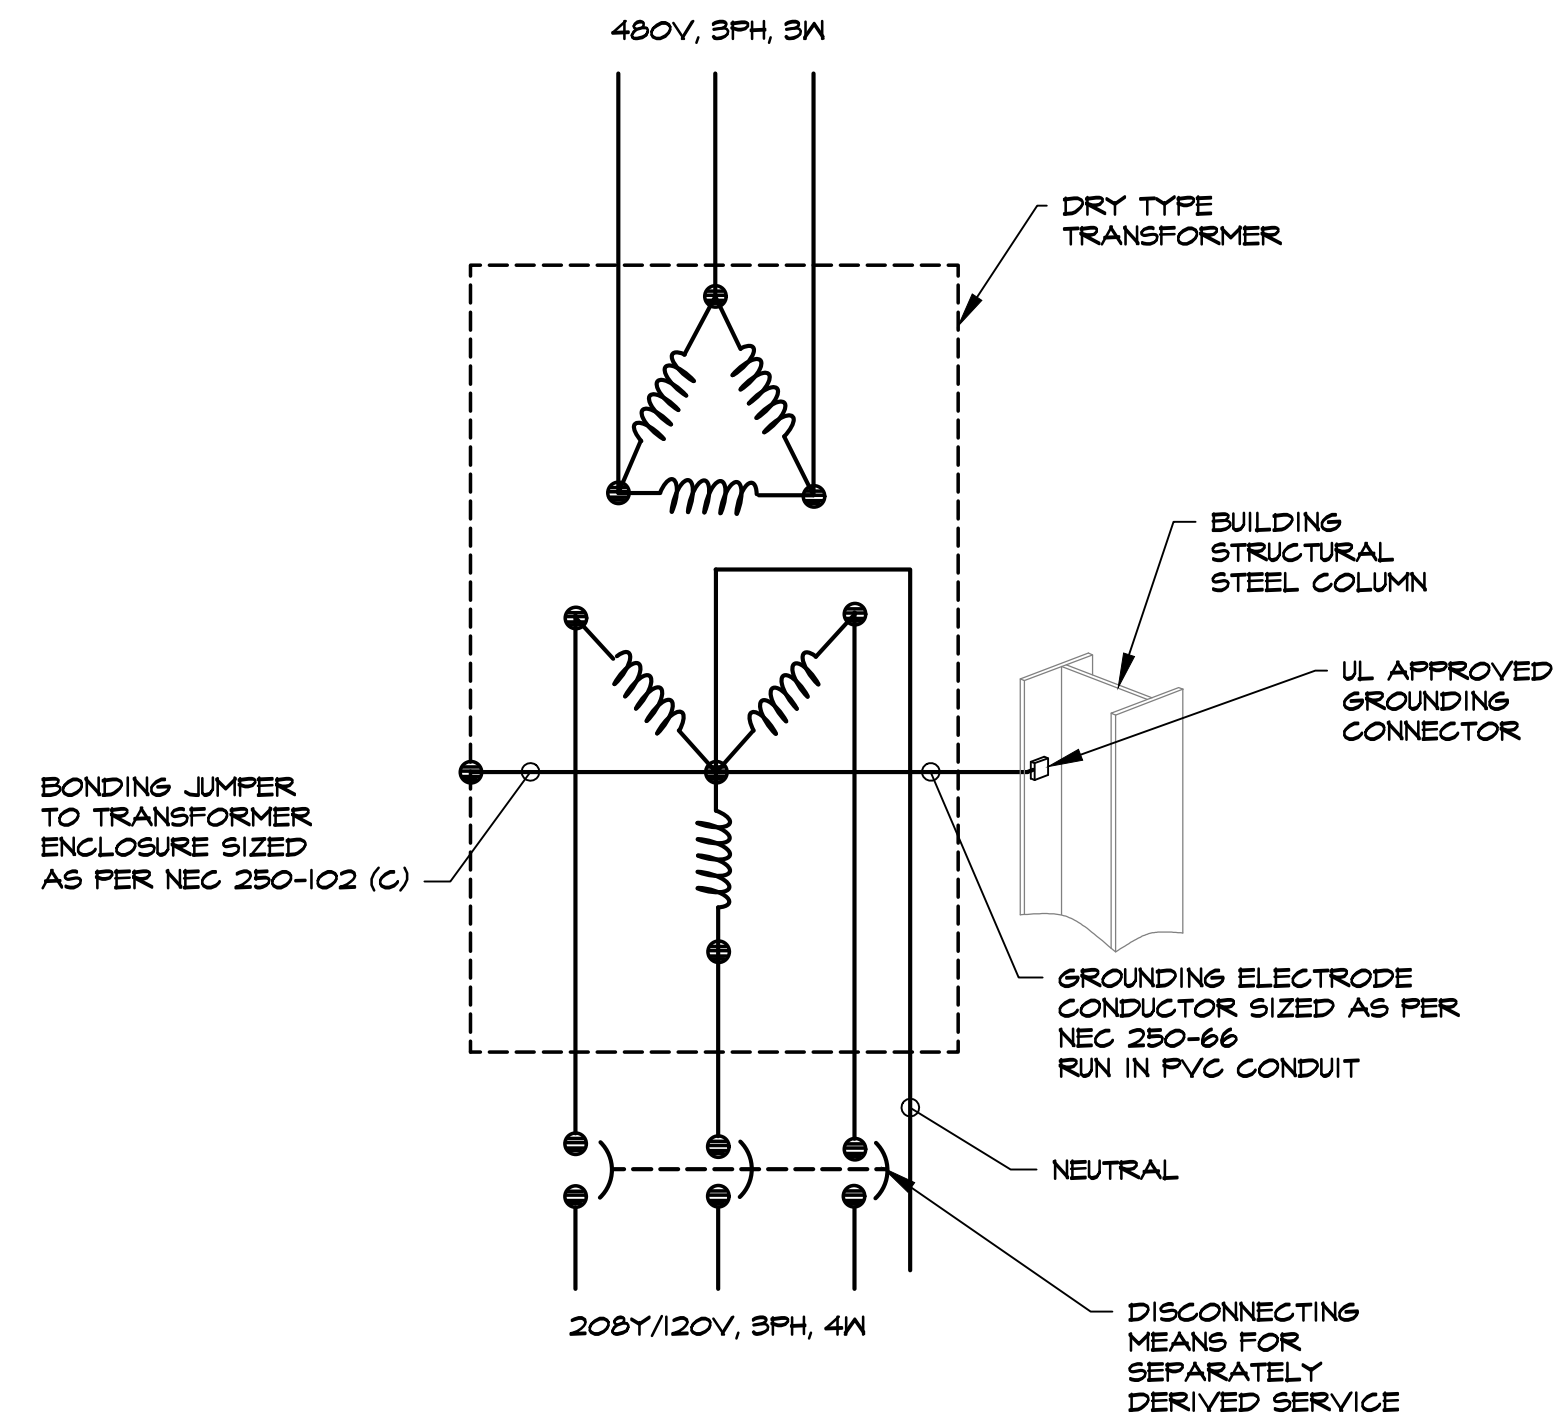

2 TYPICAL GROUNDING PROCEDURE FOR 3-PHASE DRY TYPE TRANSFORMER INSTALLATIONS
NTS

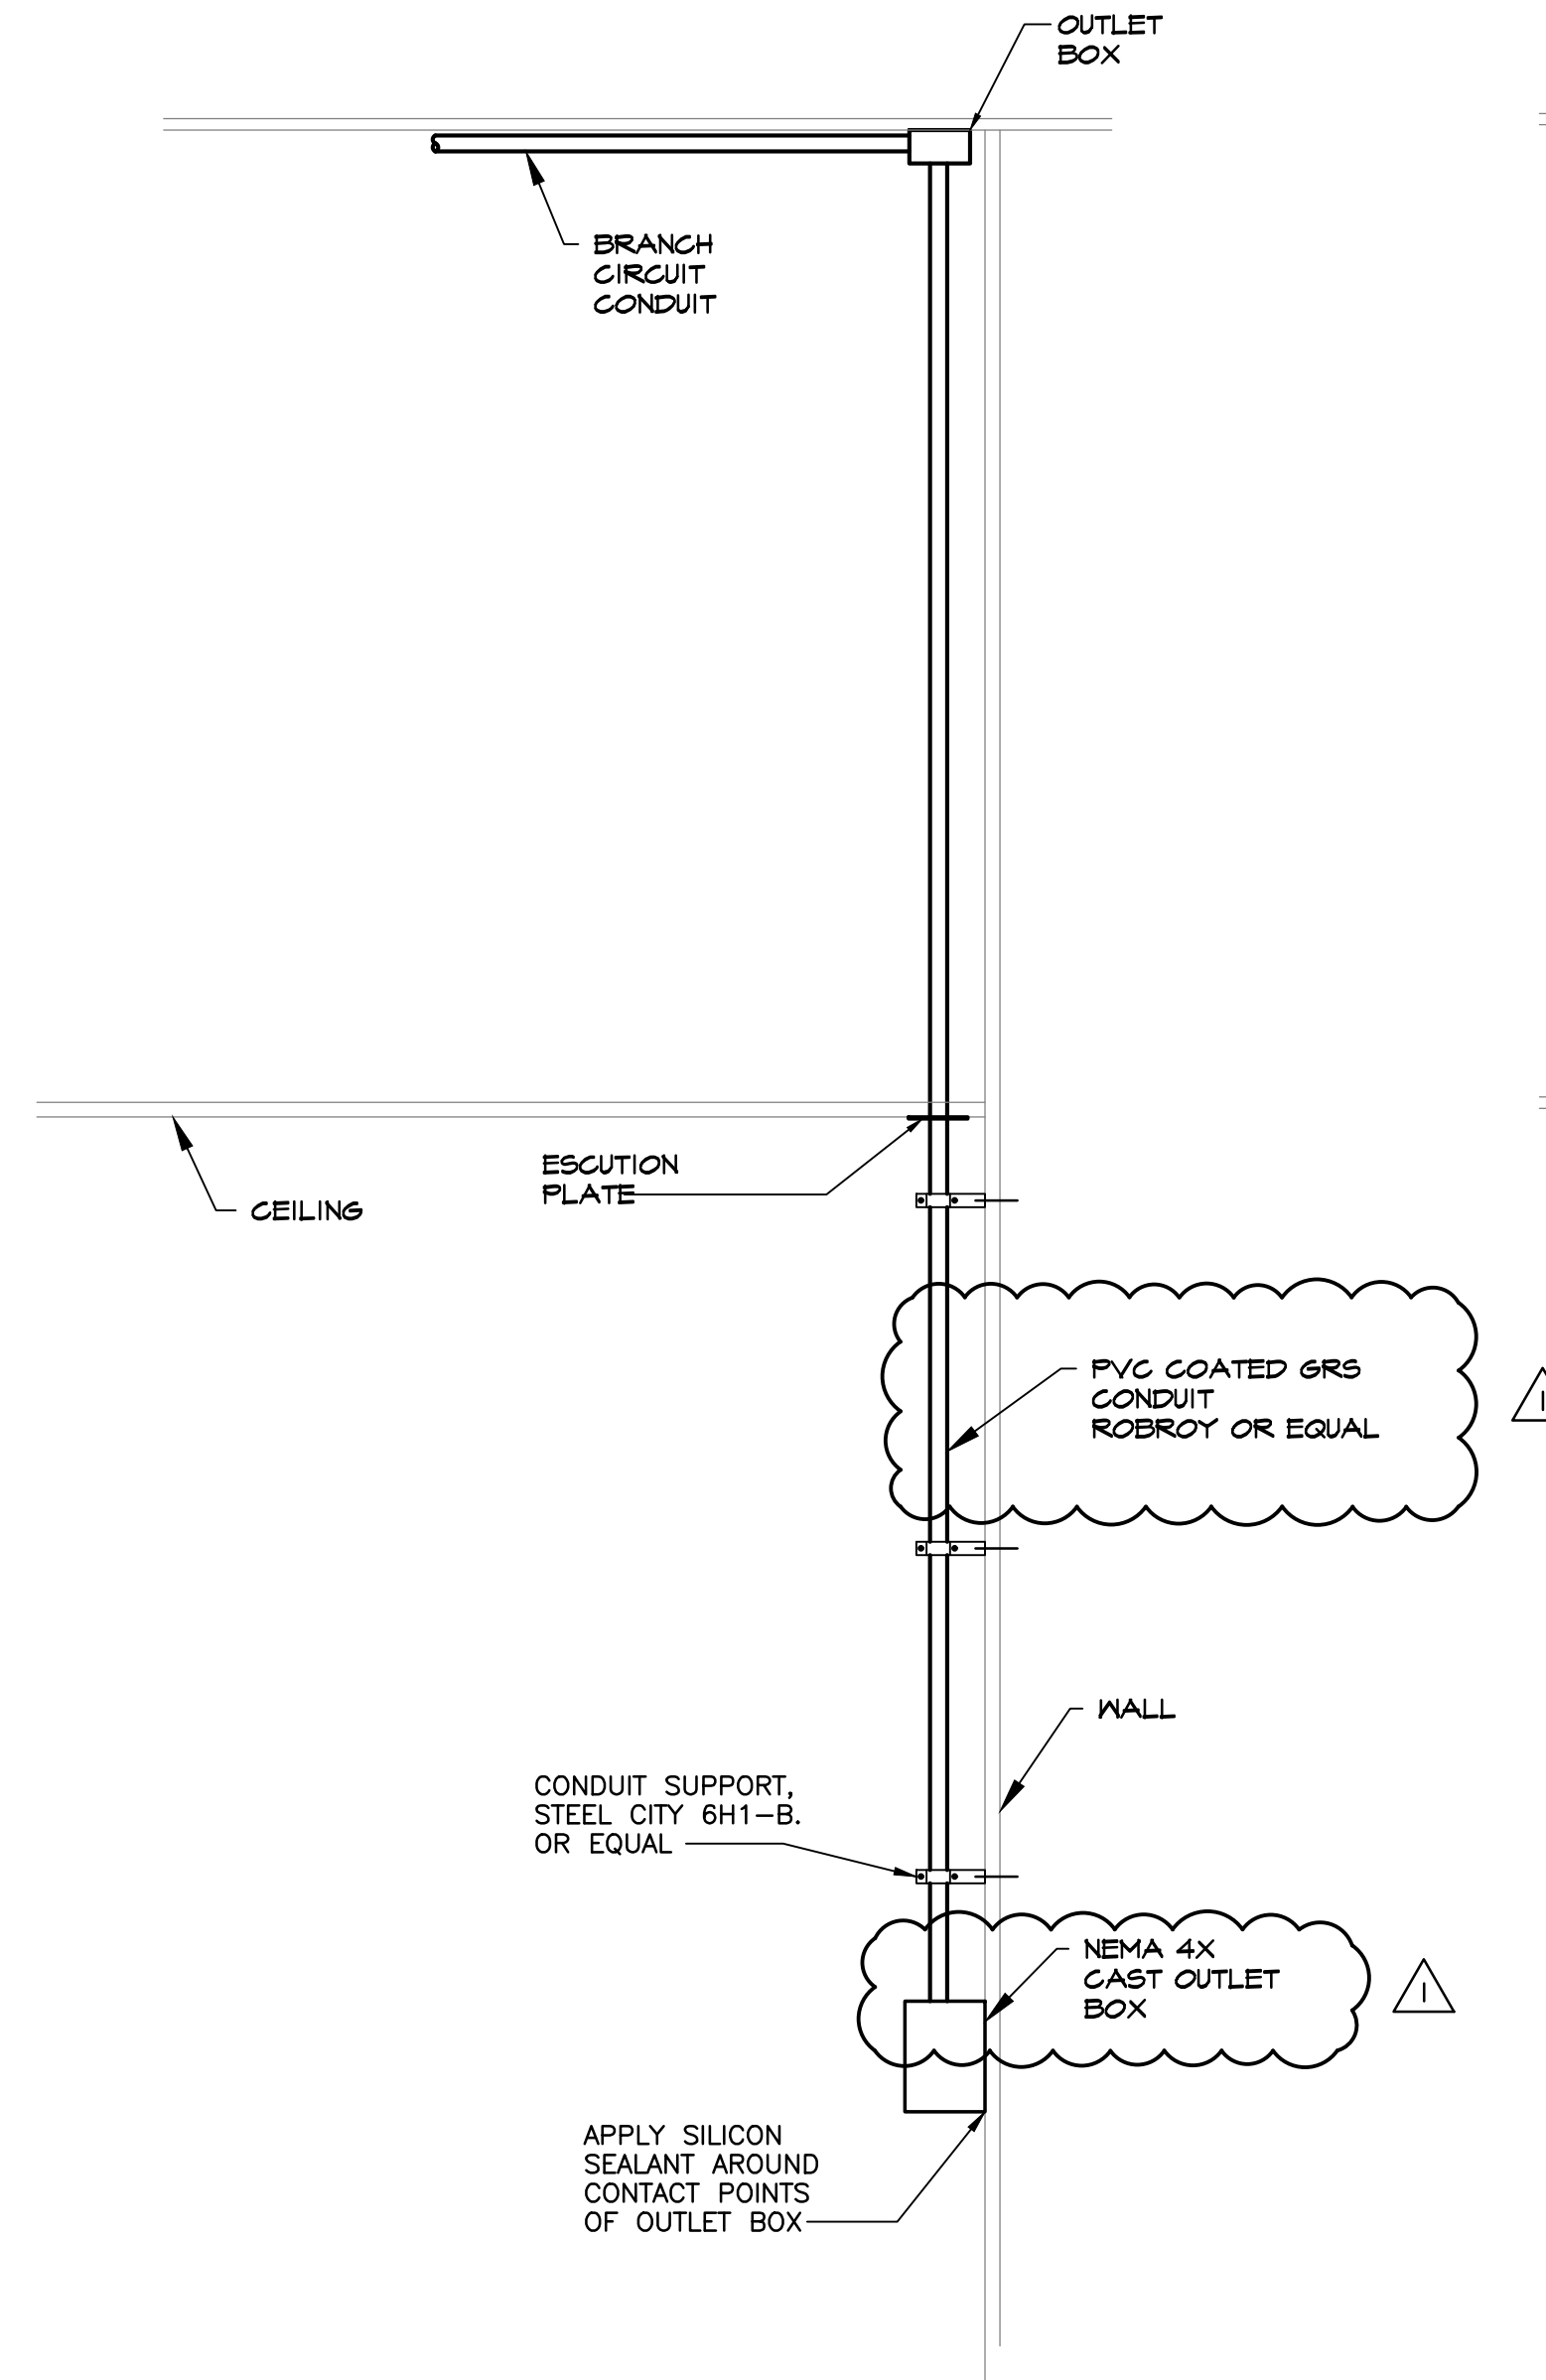

3 EXPOSED CONDUIT INSTALLATION DETAIL AT FOOD PROCESSING AREAS
NTS

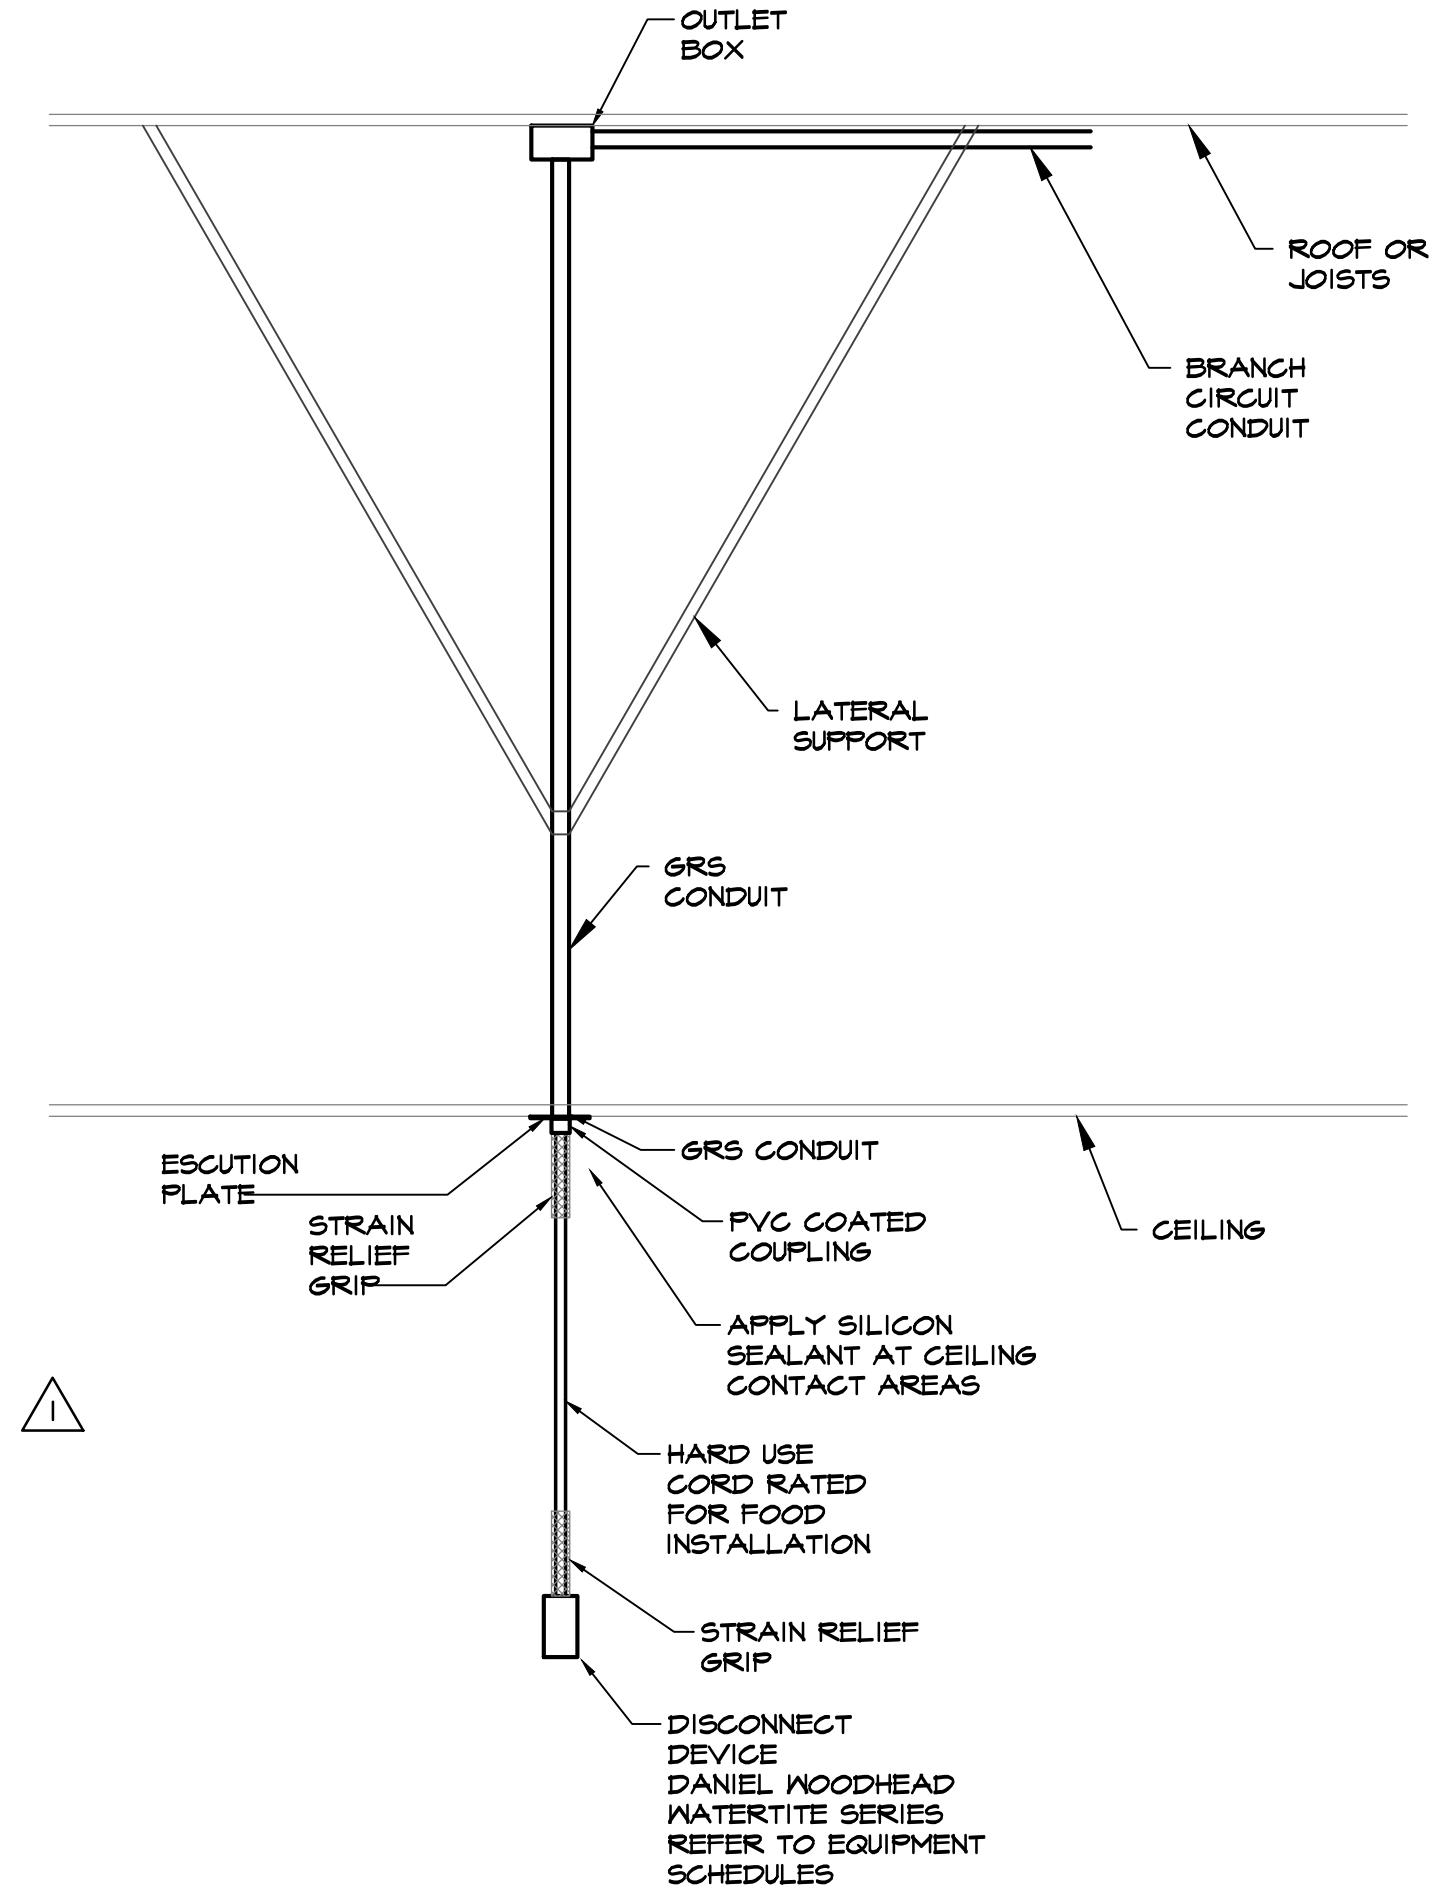

4 DISCONNECT INSTALLATION DETAIL AT FOOD PREP LINES
NTS



Renaissance Group

9700 Village Circle, Ste. 100
Lakeland, TN 38002
901.332.5533
fax: 901.332.5534
www.rgroup.biz



REV	DESCRIPTION	DATE
1	ADDENDUM #3	1/11/19

CONSTRUCTION DOCUMENTS
SCS Pilot Lab - Kitchen Renovation
3176 JACKSON AVE, MEMPHIS TN 38112

Sheet Title: ELECTRICAL DETAILS

Project No: 18035A

Drawn by: EWB

Date: 12/11/2018

E3.3